

DISCLAIMER

This drawing is a representation of concepts only and it is intended to be used as a guide of the approximate room layout. Whereas actual on-site variations or adjustments may occur, LMG cannot be held responsible for submitting this as an exact plan. All plans must comply with local safety and fire codes and be approved and/or certified by a qualified source as determined by the facility and/or local regulations. LMG takes no responsibility to certify any of the included concepts in this plan.

All contents of this drawing and design plans, ideas, and concepts indicated within are property of LMG and cannot be reproduced, redrawn, or disclosed to any individual, firm, or company without the expressed written consent of LMG.

Copyright © 2020





 
Show:

KILLERS

P04-4557

V3

LIGHTING		
Thumbnail	Item	Qty
	Martin Mac Quantum Wash	16
	Portman P2 Hexalin	5
	Robe LEDBeam 150	36
	Robe Robin Esprit	28
VIDEO		
Thumbnail	Item	Qty
SEFX		
Thumbnail	Item	Qty
CONTROL		
Thumbnail	Item	Qty
	Ghost Network Switch	2
	GrandMA2 Full-Size	2
	GrandMA 2 NPU	2
RIGGING		
Thumbnail	Item	Qty
	4' Pipe (Black (Lighting))	6
	8' Pipe (Black (Lighting))	12
	12' Box Truss 5' (Black (Lighting))	1
	12' Box Truss 8' (Black (Lighting))	9
	12' Box Truss 10' (Black (Lighting))	10
	24' x 24' Base Plate ()	6
	U-Torn 100 (Black (Lighting))	6

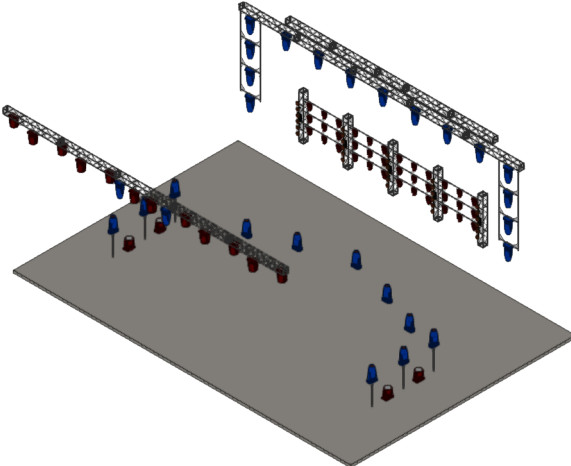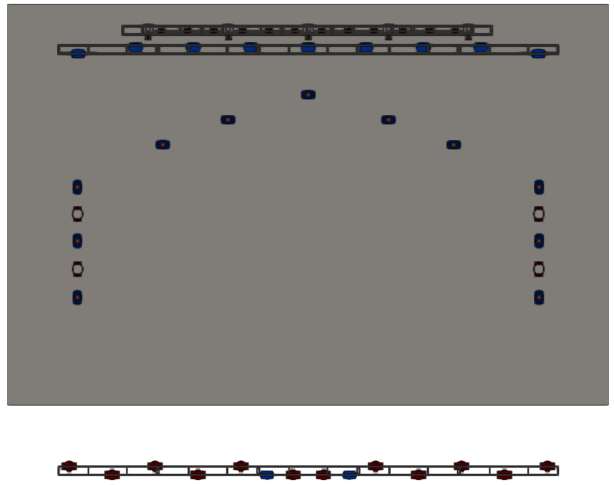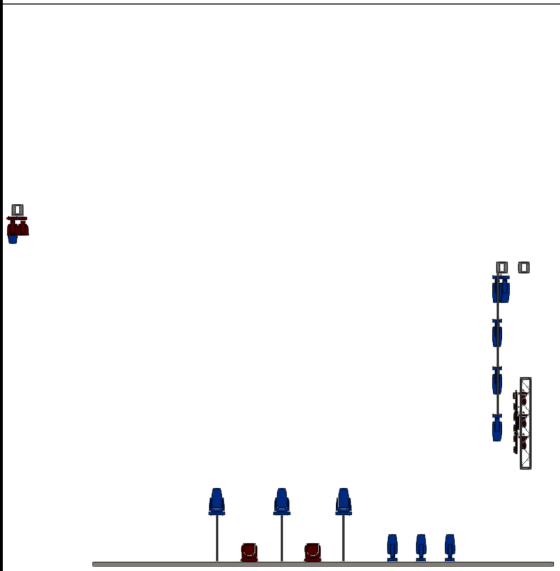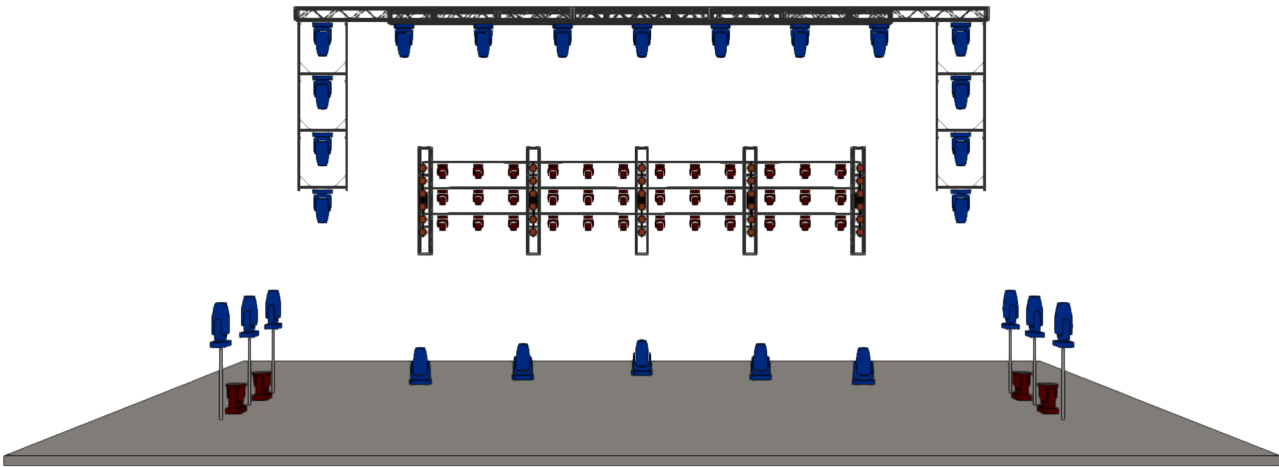

Detail:
Render

Designer:
Steven Douglas

Drawn By:
Kevin Maas

City/State:
Las Vegas, NV

Venue:
LMG Vegas Studio

Show Dates:
8/5/2020

Scale: ANSIA 8.5 x 11
NTS 1 OF 9

File Last Modified:
8/3/20
Killers_Vegas Studio V3.vwx

DISCLAIMER

This drawing is a representation of concepts only and it is intended to be used as a guide of the approximate room layout. Whereas actual on-site variations or adjustments may occur, LMG cannot be held responsible for submitting this as an exact plan. All plans must comply with local safety and fire codes and be approved and/or certified by a qualified source as determined by the facility and/or local regulations. LMG takes no responsibility to certify any of the included concepts in this plan.

All contents of this drawing and design plans, ideas, and concepts indicated within are property of LMG and cannot be reproduced, redrawn, or disclosed to any individual, firm, or company without the expressed written consent of LMG.



Copyright © 2020

Show:



P04-4557 V3

LIGHTING		
Thumbnail	Item	Qty
	Martin Mac Quantum Wash	16
	Portman P2 Hexalin	5
	Robe LEDBeam 150	36
	Robe Robin Esprit	28
VIDEO		
Thumbnail	Item	Qty
SEFX		
Thumbnail	Item	Qty
CONTROL		
Item	Qty	
Ghost Network Switch	2	
GrandMA2 Full-Size	2	
GrandMA 2 NPU	2	
RIGGING		
Thumbnail	Item	Qty
	4" Pipe (Black (Lighting))	6
	8" Pipe (Black (Lighting))	12
	12" Box Truss 5' (Black (Lighting))	1
	12" Box Truss 8' (Black (Lighting))	9
	12" Box Truss 10' (Black (Lighting))	10
	24" x 24" Base Plate ()	6
	U-Torn 100 (Black (Lighting))	6

 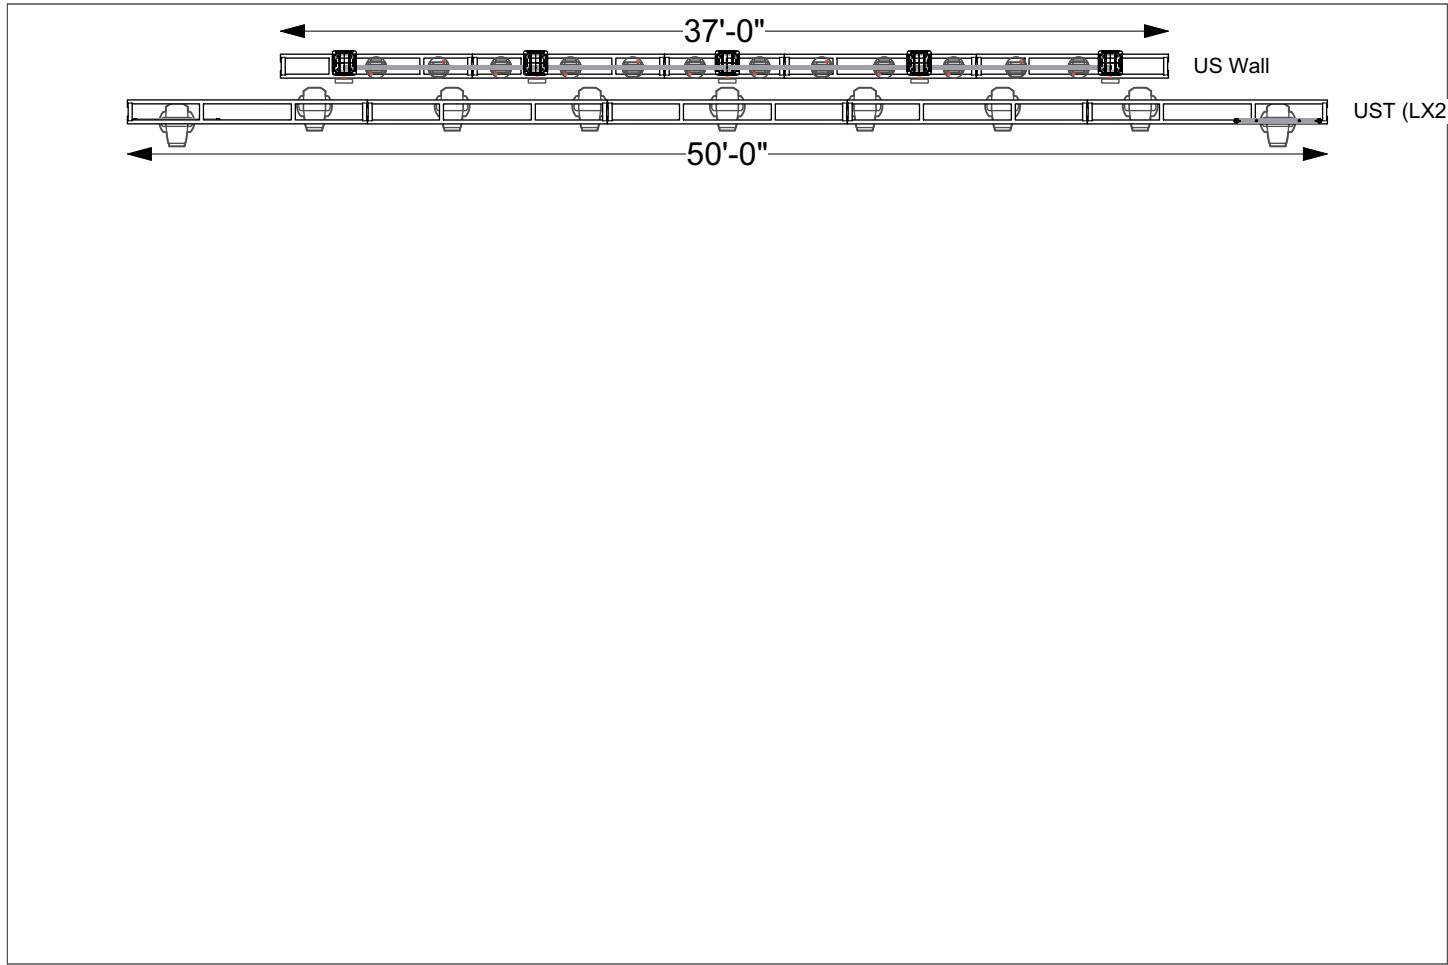

5 Truss Layout
Scale: 1/8" = 1'-0"

Detail:
Truss

Designer:
Steven Douglas

Drawn By:
Kevin Maas

City/State:
Las Vegas, NV

Venue:
LMG Vegas Studio

Show Dates:
8/5/2020

Scale: 1/8" = 1' Page: 2 OF 9
ANSI A 8.5 x 11

File Last Modified:
8/3/20
Killers_Vegas Studio V3.vwx

DISCLAIMER

This drawing is a representation of concepts only and it is intended to be used as a guide of the approximate room layout. Whereas actual on-site variations or adjustments may occur, LMG cannot be held responsible for submitting this as an exact plan. All plans must comply with local safety and fire codes and be approved and/or certified by a qualified source as determined by the facility and/or local regulations. LMG takes no responsibility to certify any of the included concepts in this plan.



All contents of this drawing and design plans, ideas, and concepts indicated within are property of LMG and cannot be reproduced, redrawn, or disclosed to any individual, firm, or company without the expressed written consent of LMG.
Copyright © 2020

Show:



P04-4557 V3

LIGHTING		
Thumbnail	Item	Qty
	Martin Mac Quantum Wash	16
	Portman P2 Hexalin	5
	Robe LEDBeam 150	36
	Robe Robin Esprite	28
VIDEO		
Thumbnail	Item	Qty
SFX		
Thumbnail	Item	Qty
CONTROL		
Thumbnail	Item	Qty
	Ghost Network Switch	2
	GrandMA2 Full-Size	2
	GrandMA 2 NPU	2
RIGGING		
Thumbnail	Item	Qty
	4" Pipe (Black (Lighting))	6
	8" Pipe (Black (Lighting))	12
	12" Box Truss 5' (Black (Lighting))	1
	12" Box Truss 8' (Black (Lighting))	9
	12" Box Truss 10' (Black (Lighting))	10
	24" x 24" Base Plate ()	6
	U-Torn 100 (Black (Lighting))	6

 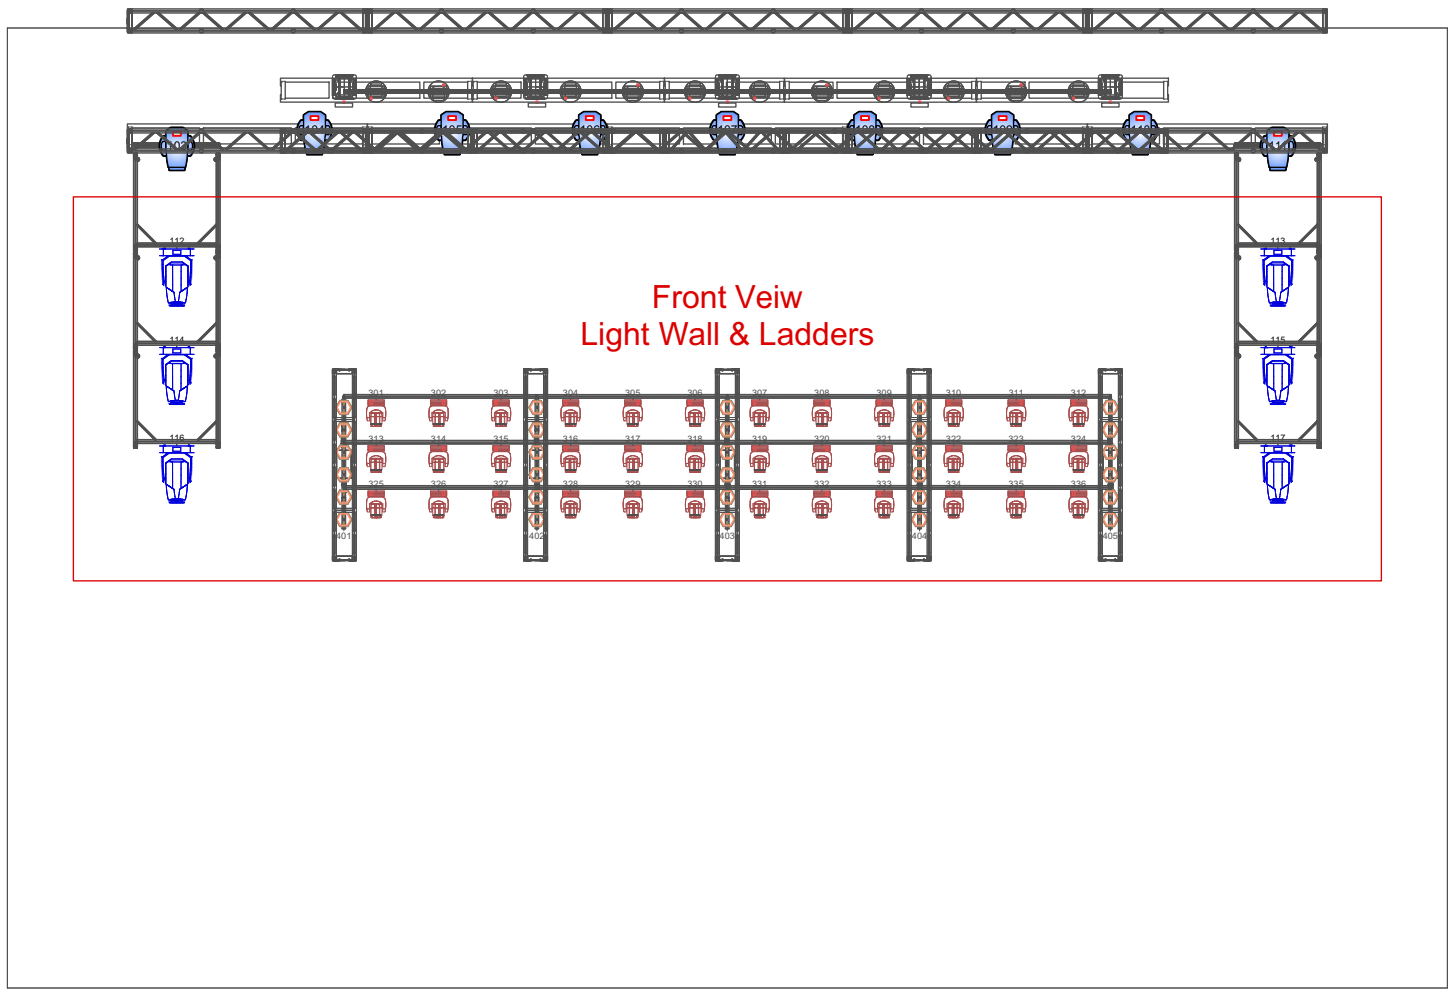

Detail:

Lighting Plan
Overhead
Designer:
Steven Douglas

Drawn By:
Kevin Maas

City/State:
Las Vegas, NV

Venue:
LMG Vegas Studio

Show Dates:
8/5/2020

Scale: 1/8" = 1'
ANSI A 8.5 x 11

Page: 3 OF 9

File Last Modified:
8/3/20
Killers_Vegas Studio V3.vwx

DISCLAIMER

This drawing is a representation of concepts only and it is intended to be used as a guide of the approximate room layout. Whereas actual on-site variations or adjustments may occur, LMG cannot be held responsible for submitting this as an exact plan. All plans must comply with local safety and fire codes and be approved and/or certified by a qualified source as determined by the facility and/or local regulations. LMG takes no responsibility to certify any of the included concepts in this plan.

All contents of this drawing and design plans, ideas, and concepts indicated within are property of LMG and cannot be reproduced, redrawn, or disclosed to any individual, firm, or company without the expressed written consent of LMG.


Copyright © 2020

Show:




P04-4557 | **V3**


LIGHTING		
Thumbnail	Item	Qty
	Martin Mac Quantum Wash	16
	Portman P2 Hexalin	5
	Robe LEDBeam 150	36
	Robe Robin Esprit	28
VIDEO		
Thumbnail	Item	Qty
SEFX		
Thumbnail	Item	Qty
CONTROL		
Thumbnail	Item	Qty
	Ghost Network Switch	2
	GrandMA2 Full-Size	2
	GrandMA 2 NPU	2
RIGGING		
Thumbnail	Item	Qty
	4" Pipe (Black (Lighting))	6
	6" Pipe (Black (Lighting))	12
	12" Box Truss 5' (Black (Lighting))	1
	12" Box Truss 8' (Black (Lighting))	9
	12" Box Truss 10' (Black (Lighting))	10
	24" x 24" Base Plate ()	6
	U-Torn 100 (Black (Lighting))	6

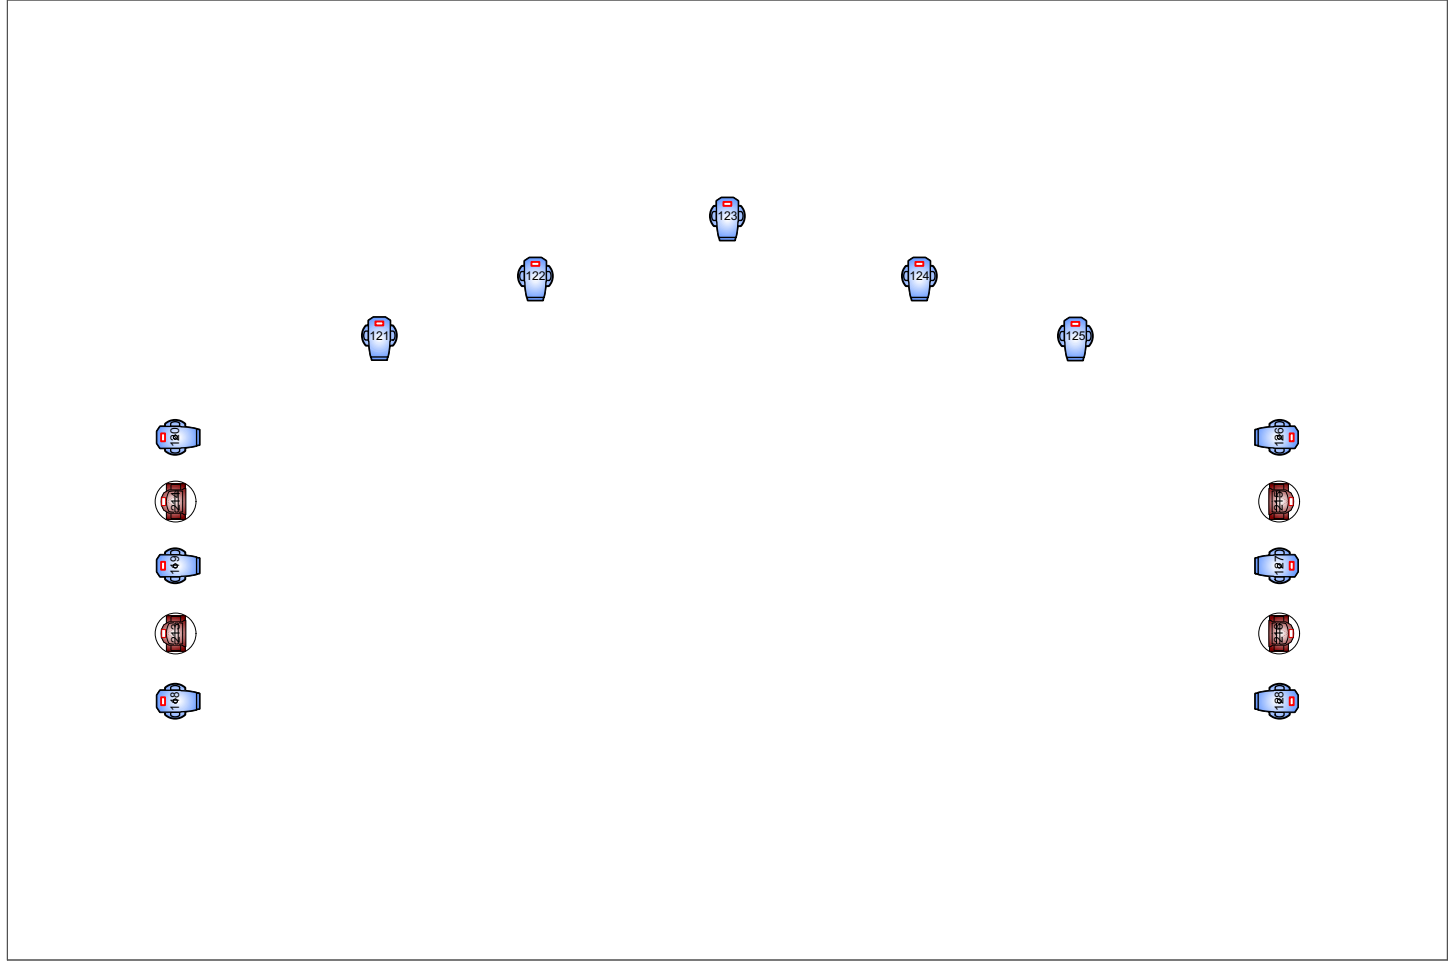

7 Lighting Plan
Scale: 1/8" = 1'-0"

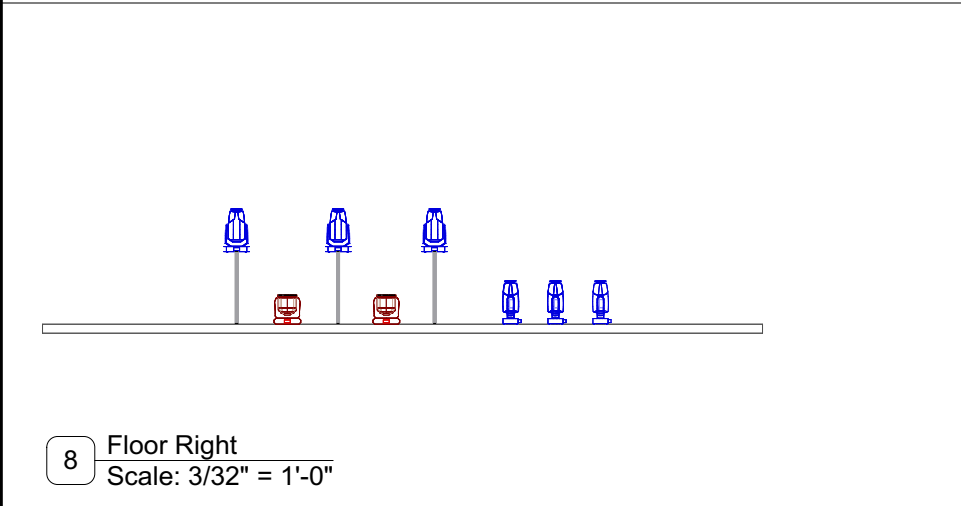

8 Floor Right
Scale: 3/32" = 1'-0"

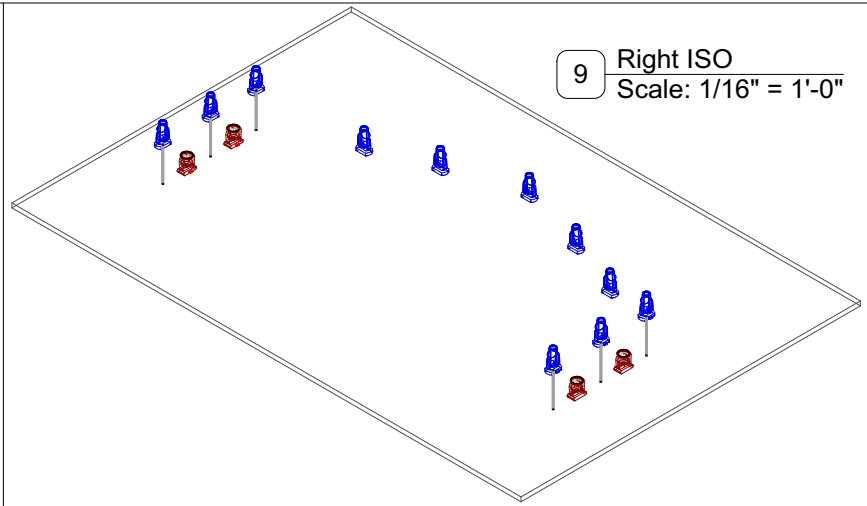

9 Right ISO
Scale: 1/16" = 1'-0"

Detail:
Lighting Plan
Floor

Designer:
Steven Douglas

Drawn By:
Kevin Maas

City/State:
Las Vegas, NV

Venue:
LMG Vegas Studio

Show Dates:
8/5/2020

Scale: Noted	Page: 4 OF 9
-----------------	-----------------

ANSI A 8.5 x 11

File Last Modified:
8/3/20
Killers_Vegas Studio V3.vwx

DISCLAIMER

This drawing is a representation of concepts only and it is intended to be used as a guide of the approximate room layout. Whereas actual on-site variations or adjustments may occur, LMG cannot be held responsible for submitting this as an exact plan. All plans must comply with local safety and fire codes and be approved and/or certified by a qualified source as determined by the facility and/or local regulations. LMG takes no responsibility to certify any of the included concepts in this plan.

All contents of this drawing and design plans, ideas, and concepts indicated within are property of LMG and cannot be reproduced, redrawn, or disclosed to any individual, firm, or company without the expressed written consent of LMG.
Copyright © 2020

Show:


KILLERS

P04-4557 | V3


Hoist Symbols Used




Scale: 1/16" = 1'-0"
Rigging 20

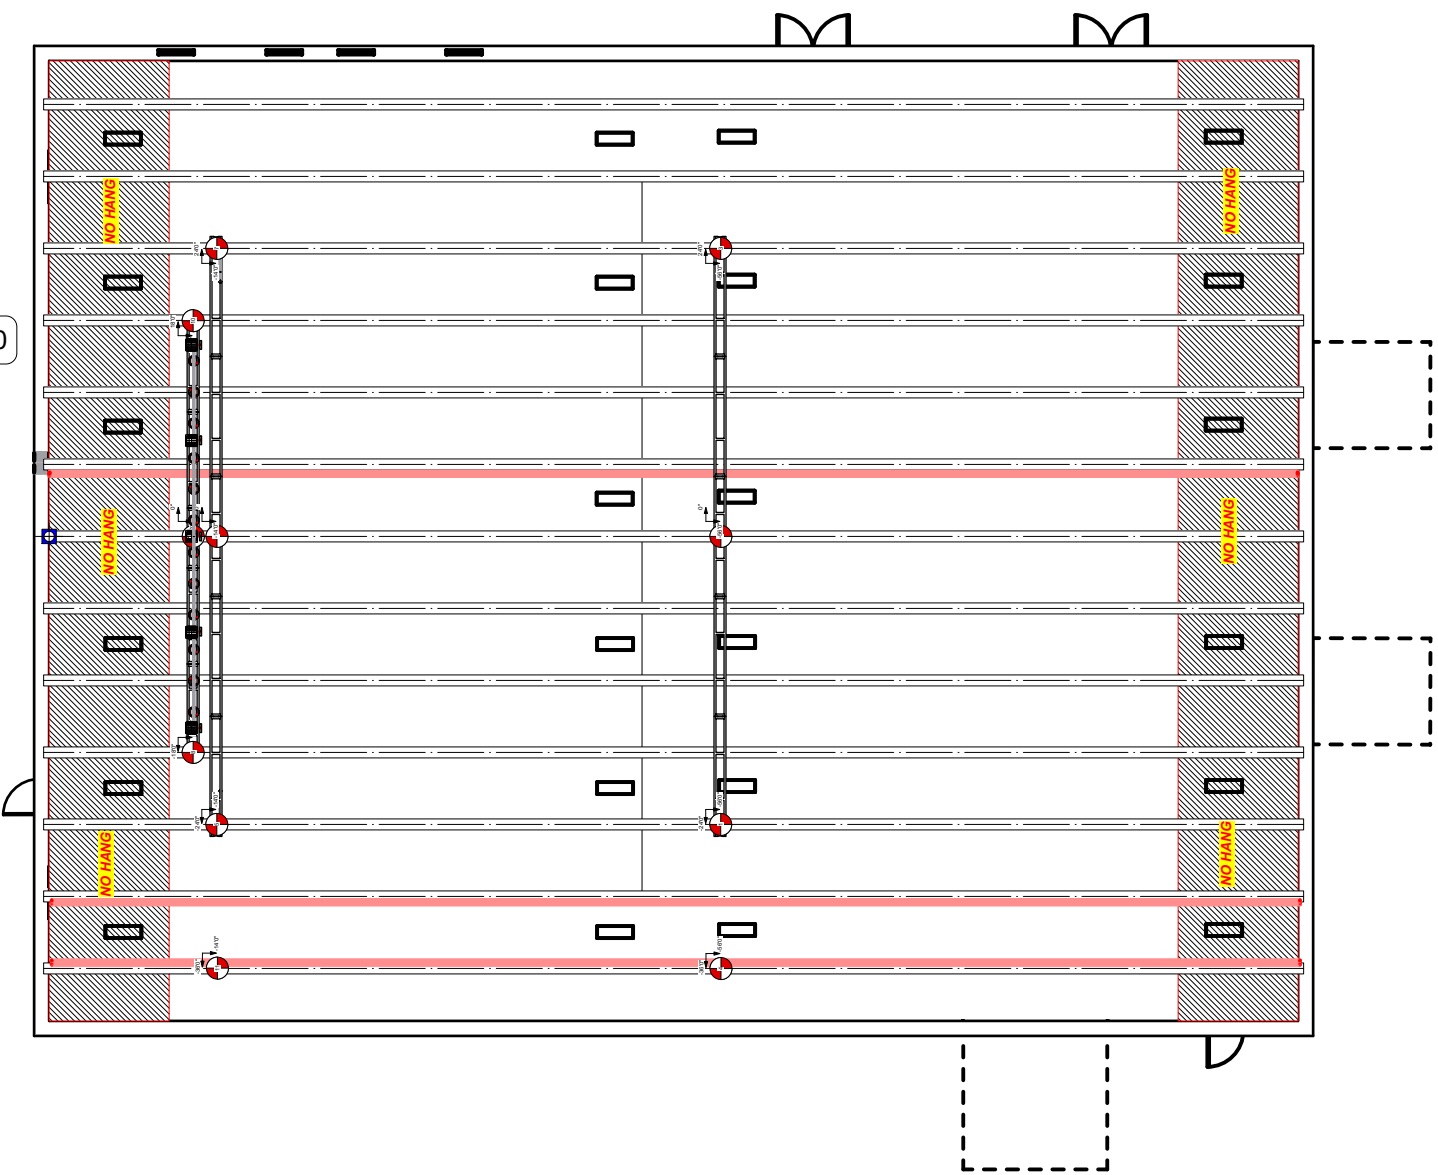

21 Rigging Right
Scale: 1/32" = 1'-0"

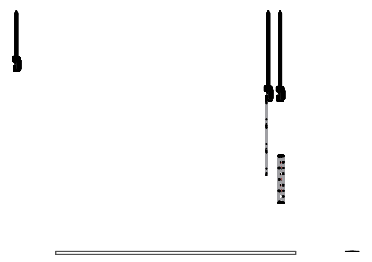

22 Rigging Front
Scale: 1/32" = 1'-0"

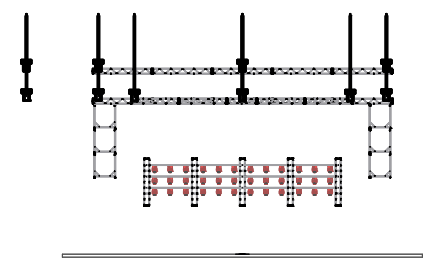

Detail:
Rigging Plot

Designer:
Steven Douglas

Drawn By:
Kevin Maas

City/State:
Las Vegas, NV

Venue:
LMG Vegas Studio

Show Dates:
8/5/2020

Scale: 1/8" = 1'	Page: 8 OF 9
---------------------	-----------------

File Last Modified:
8/3/20
Killers_Vegas Studio V3.vwx

DISCLAIMER

This drawing is a representation of concepts only and it is intended to be used as a guide of the approximate room layout. Whereas actual on-site variations or adjustments may occur, LMG cannot be held responsible for submitting this as an exact plan. All plans must comply with local safety and fire codes and be approved and/or certified by a qualified source as determined by the facility and/or local regulations. LMG takes no responsibility to certify any of the included concepts in this plan.

All contents of this drawing and design plans, ideas, and concepts indicated within are property of LMG and cannot be reproduced, redrawn, or disclosed to any individual, firm, or company without the expressed written consent of LMG.

Copyright © 2020

Show:



P04-4557 V3

LIGHTING		
Thumbnail	Item	Qty
	Martin Mac Quantum Wash	16
	Portman P2 Hexalin	5
	Robe LEDBeam 150	36
	Robe Robin Esprit	28
VIDEO		
Thumbnail	Item	Qty
SEFX		
Thumbnail	Item	Qty
CONTROL		
Thumbnail	Item	Qty
	Ghost Network Switch	2
	GrandMA2 Full-Size	2
	GrandMA 2 NPU	2
RIGGING		
Thumbnail	Item	Qty
	4" Pipe (Black (Lighting))	6
	8" Pipe (Black (Lighting))	12
	12" Box Truss 5' (Black (Lighting))	1
	12" Box Truss 8' (Black (Lighting))	9
	12" Box Truss 10' (Black (Lighting))	10
	24" x 24" Base Plate ()	6
	U-Torn 100 (Black (Lighting))	6

Detail:
Control

Designer:
Steven Douglas

Drawn By:
Kevin Maas


City/State:
Las Vegas, NV

Venue:
LMG Vegas Studio

Show Dates:
8/5/2020

Scale: NTS Page: 9 OF 9
ANSI A 8.5 x 11

File Last Modified:
8/3/20
Killers_Vegas Studio V3.vwx

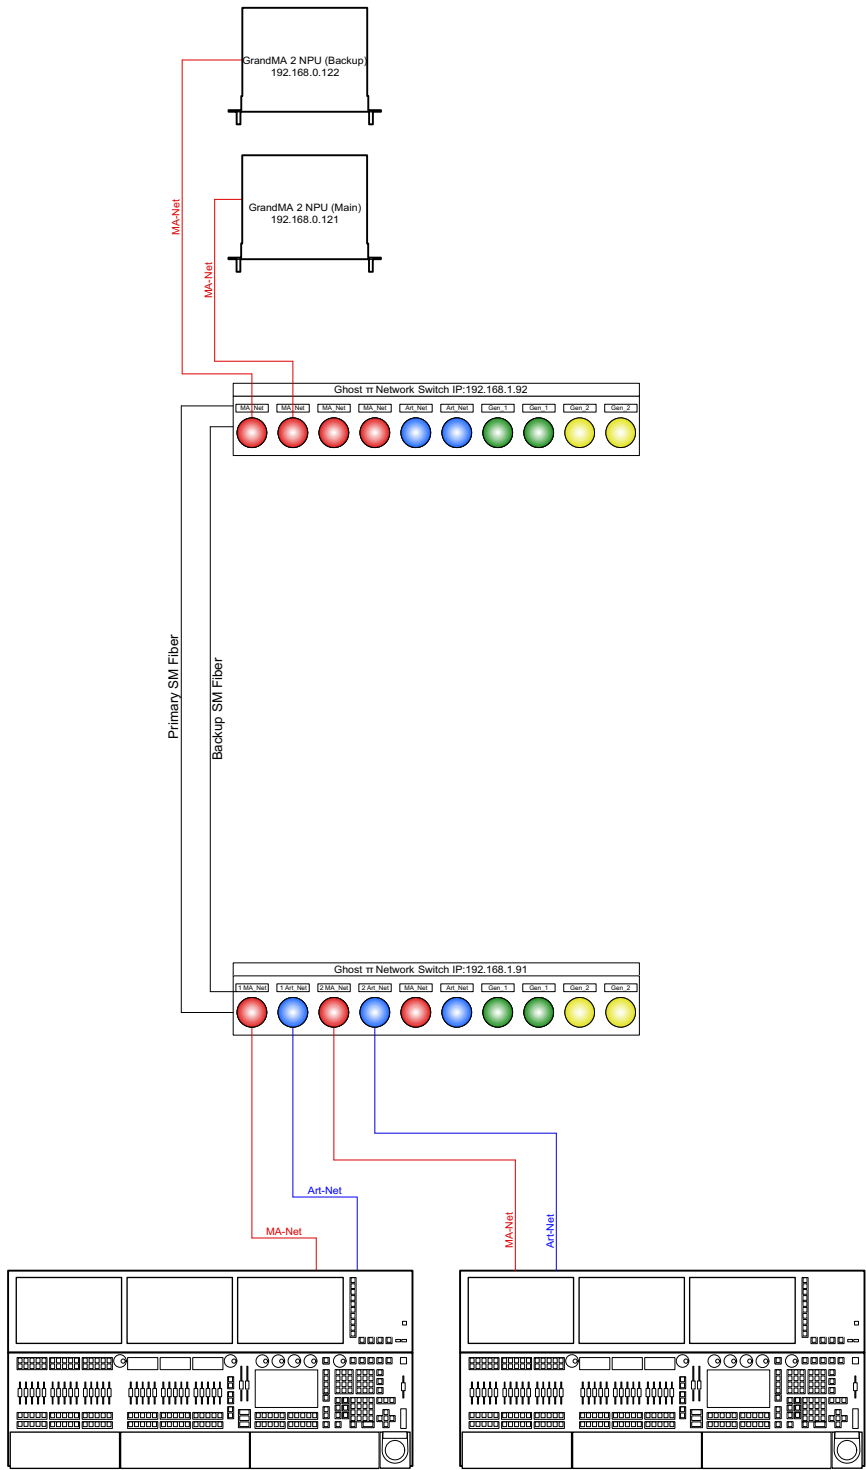

Device	IP Address
GrandMA2 Full-Size (Main)	192.168.0.101 / 2.0.0.101
GrandMA2 Full-Size (Backup)	192.168.0.102 / 2.0.0.102
GrandMA 2 NPU (Main)	192.168.0.121
GrandMA 2 NPU (Backup)	192.168.0.122
Ghost Network Switch (FOH)	192.168.1.91
Ghost Network Switch (BOH)	192.168.1.92

EQUIPMENT LIST

P04-4557



TOURING

Orlando Las Vegas Detroit
Nashville Dallas Seattle

KILLERS

8/5/2020

LIGHTING		
Item	Qty	Mode (ch)
Martin Mac Quantum Wash	16	None (33ch)
Portman P2 Hexalin	5	None (6ch)
Robe LEDBeam 150	36	None (22ch)
Robe Robin Esprite	28	None (49ch)
VIDEO		
Item	Qty	Pixel Pitch (H x V)
SFX		
Item	Qty	Mode (ch)
CONTROL		
Item	Qty	Software Version
Ghost Network Switch	2	1.0.7.5
GrandMA2 Full-Size	2	3.9.0.3
GrandMA 2 NPU	2	3.9.0.3
RIGGING		
Item	Qty	Color / Function
4' Pipe	6	Black (Lighting)
8' Pipe	12	Black (Lighting)
12" Box Truss 5'	1	Black (Lighting)
12" Box Truss 8'	9	Black (Lighting)
12" Box Truss 10'	10	Black (Lighting)
24" x 24" Base Plate	6	
U-Torm 100	6	Black (Lighting)

Distro	Number	Department	Device	IP Address
400A - Large Lighting/LED (Soca-8, 3P/L620-6, Ed -6, 50A 120/208V-1)	1	Lighting	GrandMA2 Full-Size (Main)	192.168.0.101 / 2.0.0.101
			GrandMA2 Full-Size (Backup)	192.168.0.102 / 2.0.0.102
			GrandMA 2 NPU (Main)	192.168.0.121
			GrandMA 2 NPU (Backup)	192.168.0.122
			Ghost Network Switch (FOH)	192.168.1.91
			Ghost Network Switch (BOH)	192.168.1.92

Fixture Patch

P04-4557



TOURING

Orlando Las Vegas Detroit
Nashville Dallas Seattle

KILLERS

8/5/2020

Unit Number	Inst Type	Location	Mode	DMX Footprint	Universe	Address
101	Robe Robin Esprite	DST (LX1)	Robe lighting@Robin Esprite.gdtf	49	1	1
102	Robe Robin Esprite	DST (LX1)	Robe lighting@Robin Esprite.gdtf	49	1	50
201	Martin Mac Quantum Wash	DST (LX1)	None	33	1	99
202	Martin Mac Quantum Wash	DST (LX1)	None	33	1	132
203	Martin Mac Quantum Wash	DST (LX1)	None	33	1	165
204	Martin Mac Quantum Wash	DST (LX1)	None	33	1	198
205	Martin Mac Quantum Wash	DST (LX1)	None	33	1	231
206	Martin Mac Quantum Wash	DST (LX1)	None	33	1	264
207	Martin Mac Quantum Wash	DST (LX1)	None	33	1	297
208	Martin Mac Quantum Wash	DST (LX1)	None	33	1	330
209	Martin Mac Quantum Wash	DST (LX1)	None	33	1	363
210	Martin Mac Quantum Wash	DST (LX1)	None	33	1	396
211	Martin Mac Quantum Wash	DST (LX1)	None	33	1	429
212	Martin Mac Quantum Wash	DST (LX1)	None	33	1	462
103	Robe Robin Esprite	UST (LX2)	Robe lighting@Robin Esprite.gdtf	49	2	1
104	Robe Robin Esprite	UST (LX2)	Robe lighting@Robin Esprite.gdtf	49	2	50
105	Robe Robin Esprite	UST (LX2)	Robe lighting@Robin Esprite.gdtf	49	2	99
106	Robe Robin Esprite	UST (LX2)	Robe lighting@Robin Esprite.gdtf	49	2	148
107	Robe Robin Esprite	UST (LX2)	Robe lighting@Robin Esprite.gdtf	49	2	197
108	Robe Robin Esprite	UST (LX2)	Robe lighting@Robin Esprite.gdtf	49	2	246
109	Robe Robin Esprite	UST (LX2)	Robe lighting@Robin Esprite.gdtf	49	2	295
110	Robe Robin Esprite	UST (LX2)	Robe lighting@Robin Esprite.gdtf	49	2	344
111	Robe Robin Esprite	UST (LX2)	Robe lighting@Robin Esprite.gdtf	49	2	393
112	Robe Robin Esprite	SR Ladder	Robe lighting@Robin Esprite.gdtf	49	3	1
114	Robe Robin Esprite	SR Ladder	Robe lighting@Robin Esprite.gdtf	49	3	50
116	Robe Robin Esprite	SR Ladder	Robe lighting@Robin Esprite.gdtf	49	3	99
113	Robe Robin Esprite	SL Ladder	Robe lighting@Robin Esprite.gdtf	49	3	148
115	Robe Robin Esprite	SL Ladder	Robe lighting@Robin Esprite.gdtf	49	3	197
117	Robe Robin Esprite	SL Ladder	Robe lighting@Robin Esprite.gdtf	49	3	246
301	Robe LEDBeam 150	US Wall	ghting@Robin LEDBeam 150 FW RGE	22	4	1
302	Robe LEDBeam 150	US Wall	ghting@Robin LEDBeam 150 FW RGE	22	4	23
303	Robe LEDBeam 150	US Wall	ghting@Robin LEDBeam 150 FW RGE	22	4	45
304	Robe LEDBeam 150	US Wall	ghting@Robin LEDBeam 150 FW RGE	22	4	67
305	Robe LEDBeam 150	US Wall	ghting@Robin LEDBeam 150 FW RGE	22	4	89
306	Robe LEDBeam 150	US Wall	ghting@Robin LEDBeam 150 FW RGE	22	4	111
313	Robe LEDBeam 150	US Wall	ghting@Robin LEDBeam 150 FW RGE	22	4	133
314	Robe LEDBeam 150	US Wall	ghting@Robin LEDBeam 150 FW RGE	22	4	155
315	Robe LEDBeam 150	US Wall	ghting@Robin LEDBeam 150 FW RGE	22	4	177
316	Robe LEDBeam 150	US Wall	ghting@Robin LEDBeam 150 FW RGE	22	4	199
317	Robe LEDBeam 150	US Wall	ghting@Robin LEDBeam 150 FW RGE	22	4	221
318	Robe LEDBeam 150	US Wall	ghting@Robin LEDBeam 150 FW RGE	22	4	243
325	Robe LEDBeam 150	US Wall	ghting@Robin LEDBeam 150 FW RGE	22	4	265
326	Robe LEDBeam 150	US Wall	ghting@Robin LEDBeam 150 FW RGE	22	4	287
327	Robe LEDBeam 150	US Wall	ghting@Robin LEDBeam 150 FW RGE	22	4	309
328	Robe LEDBeam 150	US Wall	ghting@Robin LEDBeam 150 FW RGE	22	4	331
329	Robe LEDBeam 150	US Wall	ghting@Robin LEDBeam 150 FW RGE	22	4	353
330	Robe LEDBeam 150	US Wall	ghting@Robin LEDBeam 150 FW RGE	22	4	375
401	Portman P2 Hexalin	US Wall	None	6	4	397
402	Portman P2 Hexalin	US Wall	None	6	4	403
403	Portman P2 Hexalin	US Wall	None	6	4	409
307	Robe LEDBeam 150	US Wall	ghting@Robin LEDBeam 150 FW RGE	22	5	1
308	Robe LEDBeam 150	US Wall	ghting@Robin LEDBeam 150 FW RGE	22	5	23
309	Robe LEDBeam 150	US Wall	ghting@Robin LEDBeam 150 FW RGE	22	5	45
310	Robe LEDBeam 150	US Wall	ghting@Robin LEDBeam 150 FW RGE	22	5	67
311	Robe LEDBeam 150	US Wall	ghting@Robin LEDBeam 150 FW RGE	22	5	89
312	Robe LEDBeam 150	US Wall	ghting@Robin LEDBeam 150 FW RGE	22	5	111
319	Robe LEDBeam 150	US Wall	ghting@Robin LEDBeam 150 FW RGE	22	5	133
320	Robe LEDBeam 150	US Wall	ghting@Robin LEDBeam 150 FW RGE	22	5	155
321	Robe LEDBeam 150	US Wall	ghting@Robin LEDBeam 150 FW RGE	22	5	177
322	Robe LEDBeam 150	US Wall	ghting@Robin LEDBeam 150 FW RGE	22	5	199
323	Robe LEDBeam 150	US Wall	ghting@Robin LEDBeam 150 FW RGE	22	5	221
324	Robe LEDBeam 150	US Wall	ghting@Robin LEDBeam 150 FW RGE	22	5	243
331	Robe LEDBeam 150	US Wall	ghting@Robin LEDBeam 150 FW RGE	22	5	265
332	Robe LEDBeam 150	US Wall	ghting@Robin LEDBeam 150 FW RGE	22	5	287
333	Robe LEDBeam 150	US Wall	ghting@Robin LEDBeam 150 FW RGE	22	5	309
334	Robe LEDBeam 150	US Wall	ghting@Robin LEDBeam 150 FW RGE	22	5	331
335	Robe LEDBeam 150	US Wall	ghting@Robin LEDBeam 150 FW RGE	22	5	353
336	Robe LEDBeam 150	US Wall	ghting@Robin LEDBeam 150 FW RGE	22	5	375
404	Portman P2 Hexalin	US Wall	None	6	5	397
405	Portman P2 Hexalin	US Wall	None	6	5	403
118	Robe Robin Esprite	SR Floor	None	49	6	1
119	Robe Robin Esprite	SR Floor	None	49	6	50
120	Robe Robin Esprite	SR Floor	None	49	6	99
121	Robe Robin Esprite	US Floor	None	49	6	148
122	Robe Robin Esprite	US Floor	None	49	6	197
123	Robe Robin Esprite	US Floor	None	49	6	246
213	Martin Mac Quantum Wash	SR Floor	None	33	6	295
214	Martin Mac Quantum Wash	SR Floor	None	33	6	328
128	Robe Robin Esprite	SL Floor	None	49	7	1
127	Robe Robin Esprite	SL Floor	None	49	7	50
126	Robe Robin Esprite	SL Floor	None	49	7	99
125	Robe Robin Esprite	US Floor	None	49	7	148
124	Robe Robin Esprite	US Floor	None	49	7	197
216	Martin Mac Quantum Wash	SL Floor	None	33	7	295
215	Martin Mac Quantum Wash	SL Floor	None	33	7	328

Motor Detail

P04-4557



TOURING

Orlando Las Vegas Detroit
Nashville Dallas Seattle

KILLERS

8/5/2020

Hoist #	Hoist Lable	Location	Hoist Type	Function	Total Point Load	X	Y	Trim Hieght
1	L1	DST (LX1)	1 Ton	Lights	378.80 lb	-24'0"	-56'0"	31'6"
2	L2	DST (LX1)	1 Ton	Lights	802.80 lb	0"	-56'0"	31'6"
3	L3	DST (LX1)	1 Ton	Lights	378.80 lb	24'0"	-56'0"	31'6"
4	L4	DST (CP)	1 Ton	Lights	482.80 lb	-36'0"	-56'0"	31'6"
5	L5	UST (LX2)	1 Ton	Lights	442.80 lb	-24'0"	-14'0"	26'7"
6	L6	UST (LX2)	1 Ton	Lights	1022.80 lb	0"	-14'0"	26'7"
7	L7	UST (LX2)	1 Ton	Lights	442.80 lb	24'0"	-14'0"	26'7"
8	L8	Light Wall	1 Ton	Lights	400.80 lb	-18'0"	-12'0"	26'6"
9	L9	Light Wall	1 Ton	Lights	932.80 lb	0"	-12'0"	26'6"
10	L10	Light Wall	1 Ton	Lights	400.80 lb	18'0"	-12'0"	26'6"
11	L11	US (CP)	1 Ton	Lights	632.80 lb	-36'0"	-14'0"	26'7"